


## ARCHITECT NOTE:

- DETAIL FOR SUPPORTED PROGUARD DP® - DOUBLE DRAINAGE PLANE PANELS.
- ENGINEER OF RECORD TO SELECT PROGUARD DP® SCREW SPACING USING NTA REPORT TRIG030116-28.

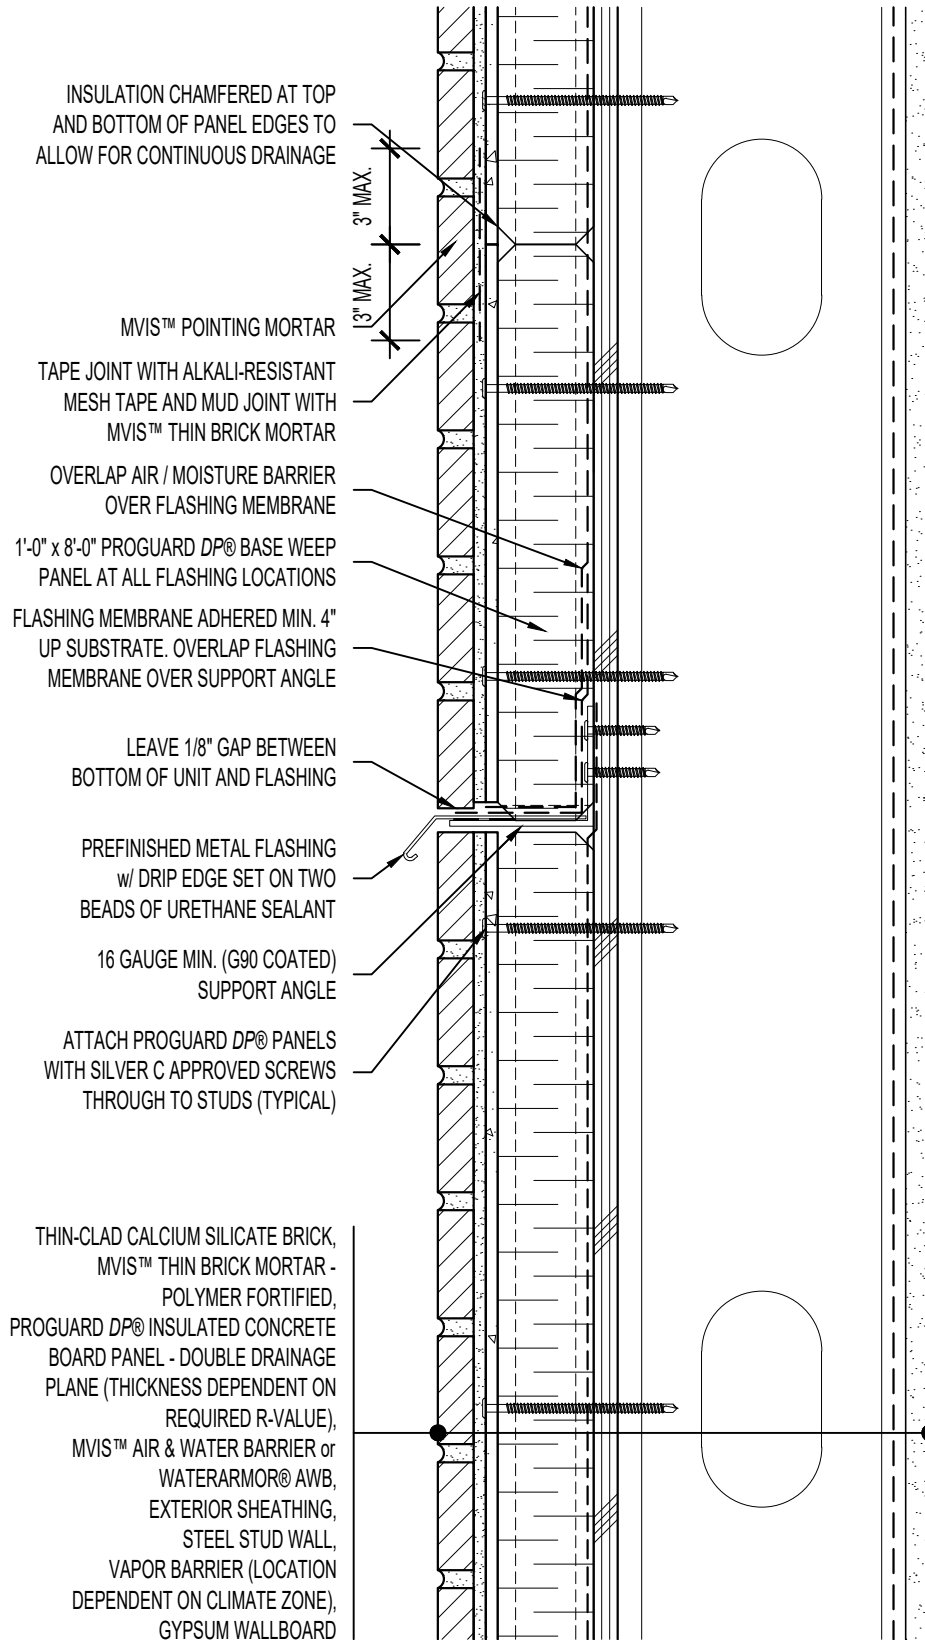

**ARRISCRAFT-CADD**

TITLE:

FLASHING SUPPORT  
ANGLE DETAIL

DETAIL No:

SSETB - DP2S

**U081**

DATE DRAWN:

02 Mar 2022

SCALE:

3"=1'-0"

DRAWN BY:

TRI